


STEAMBOAT SPRINGS CITY HALL AND FIRE RESCUE

Attachment 2


137 10TH STREET

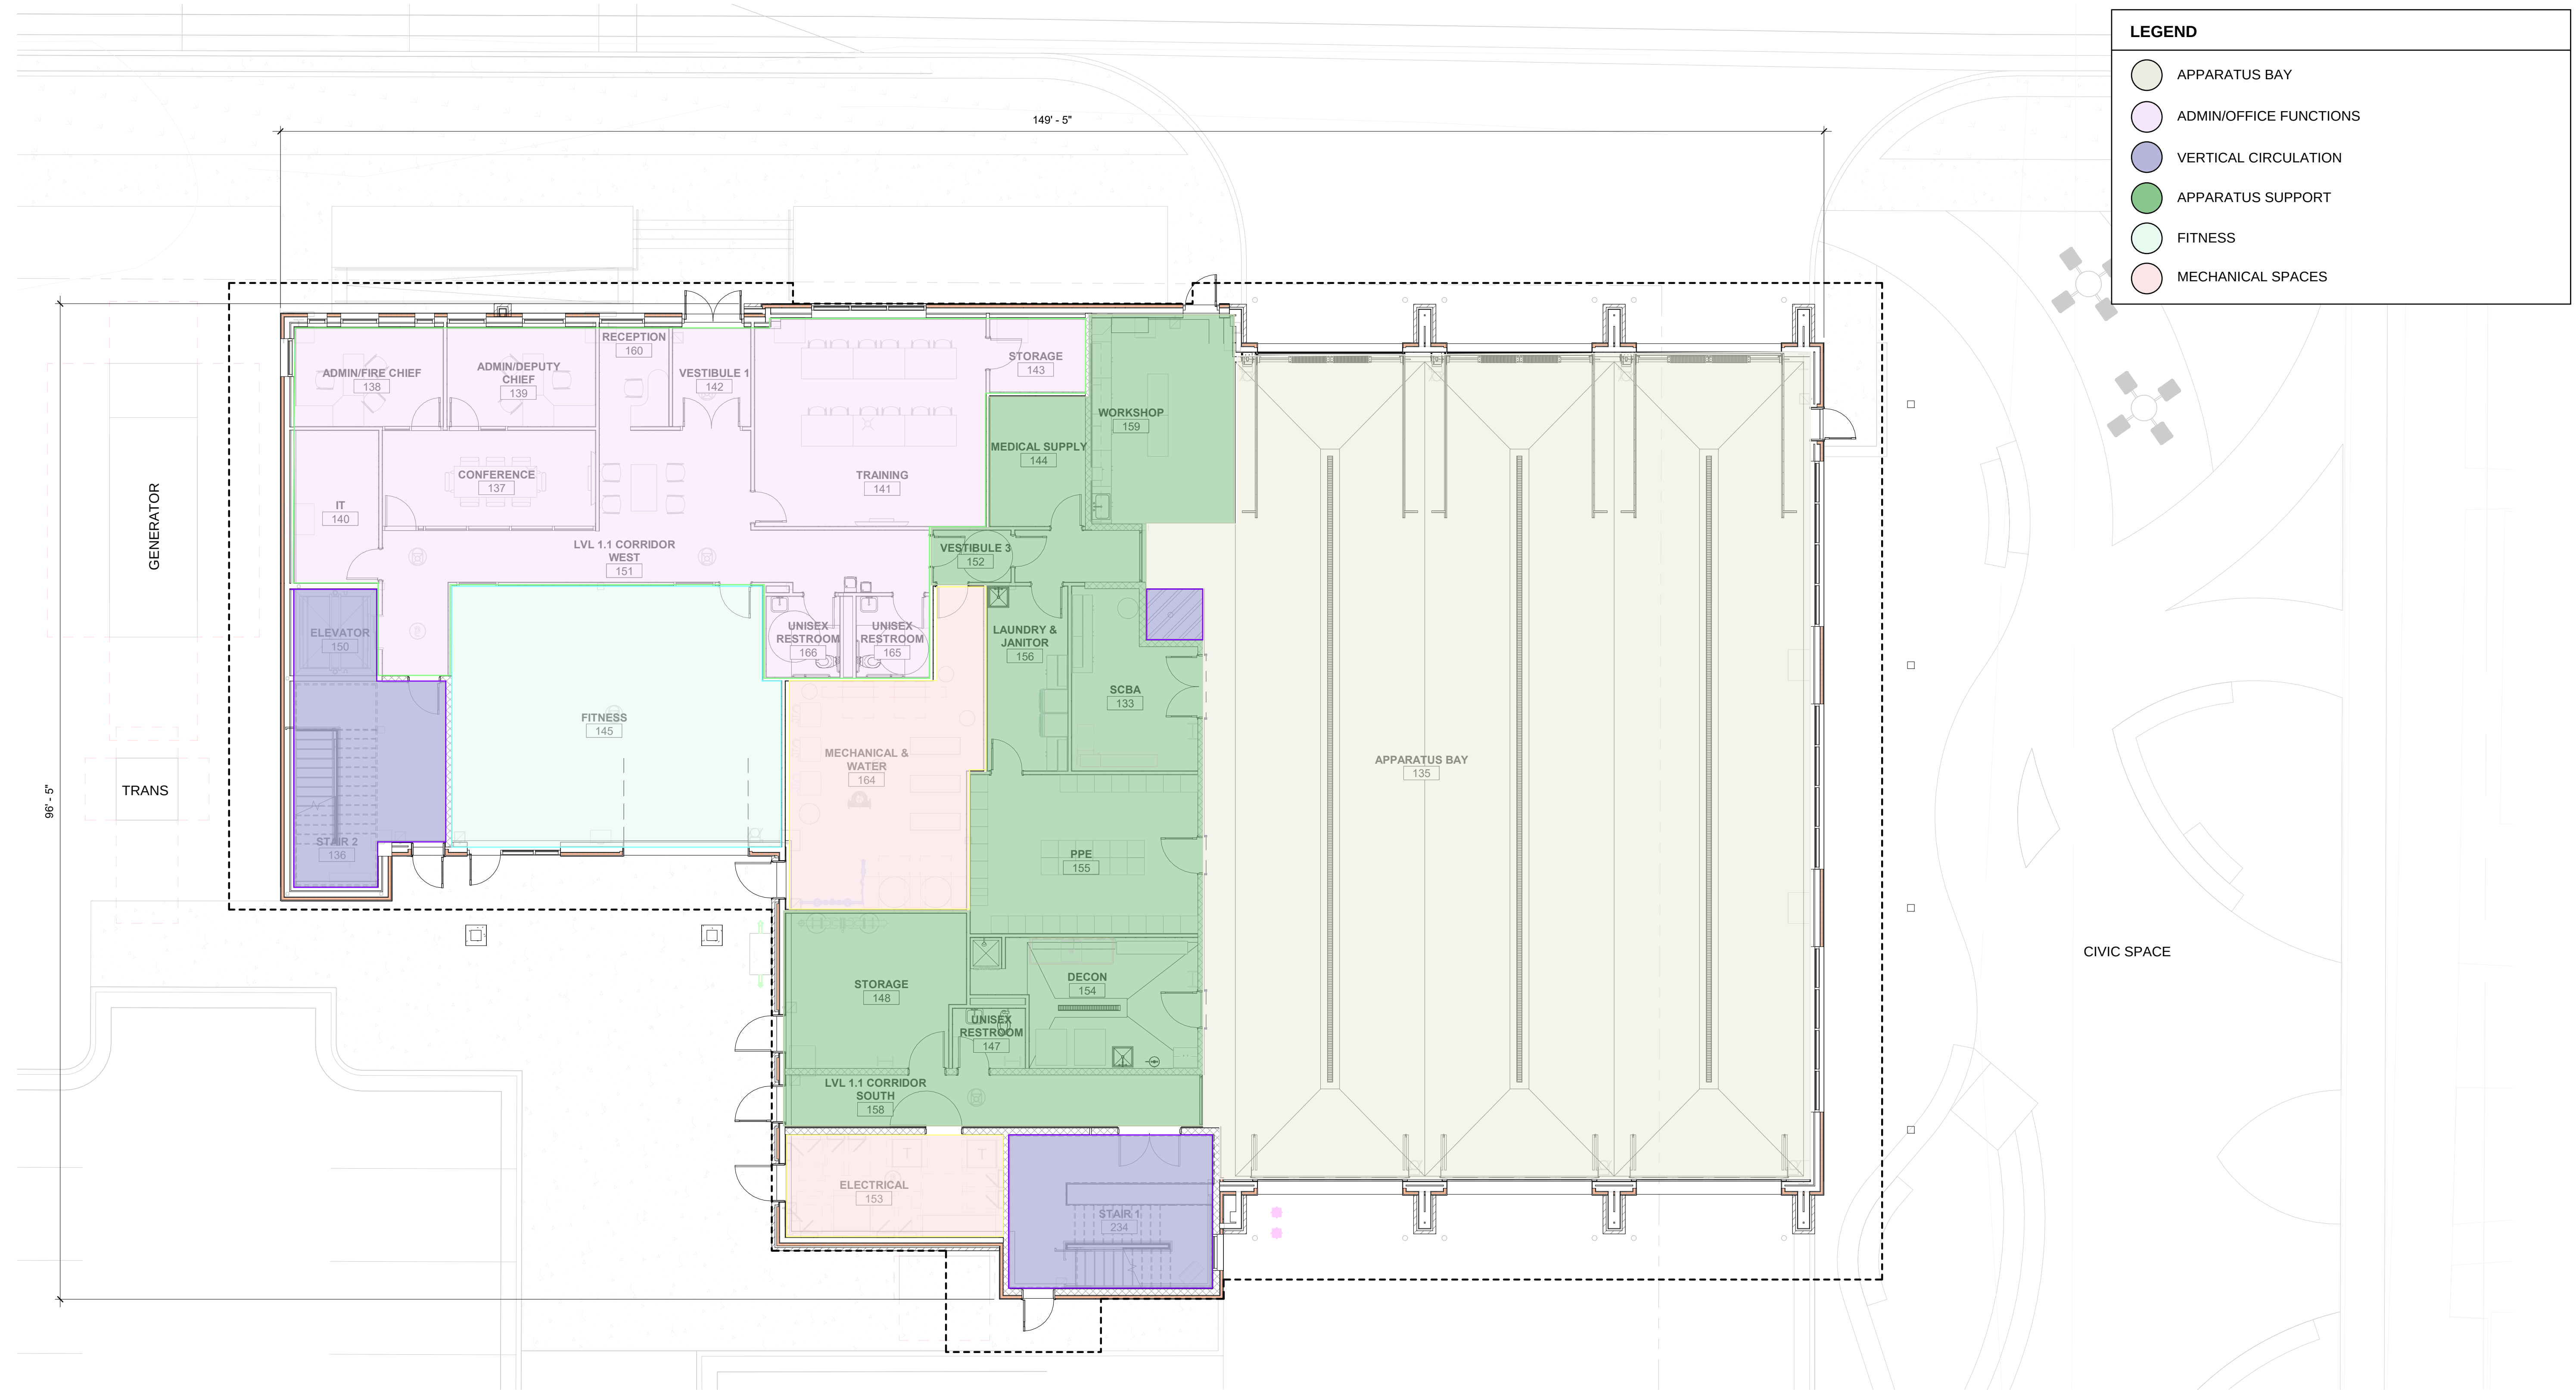

LEGEND

- APPARATUS BAY
- ADMIN/OFFICE FUNCTIONS
- VERTICAL CIRCULATION
- APPARATUS SUPPORT
- FITNESS
- MECHANICAL SPACES

1 FLOOR PLAN - LEVEL 1 OVERALL
1/8" = 1'-0"

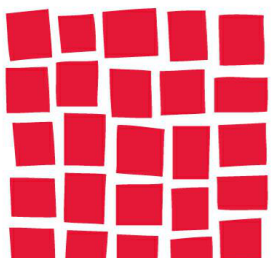

DAVIS
PARTNERSHIP
ARCHITECTS




ANDERSON
HALLAS
ARCHITECTS

LEVEL 1 FLOOR PLAN

SHEET NUMBER:
1

STEAMBOAT SPRINGS CITY HALL AND FIRE RESCUE



137 10TH STREET

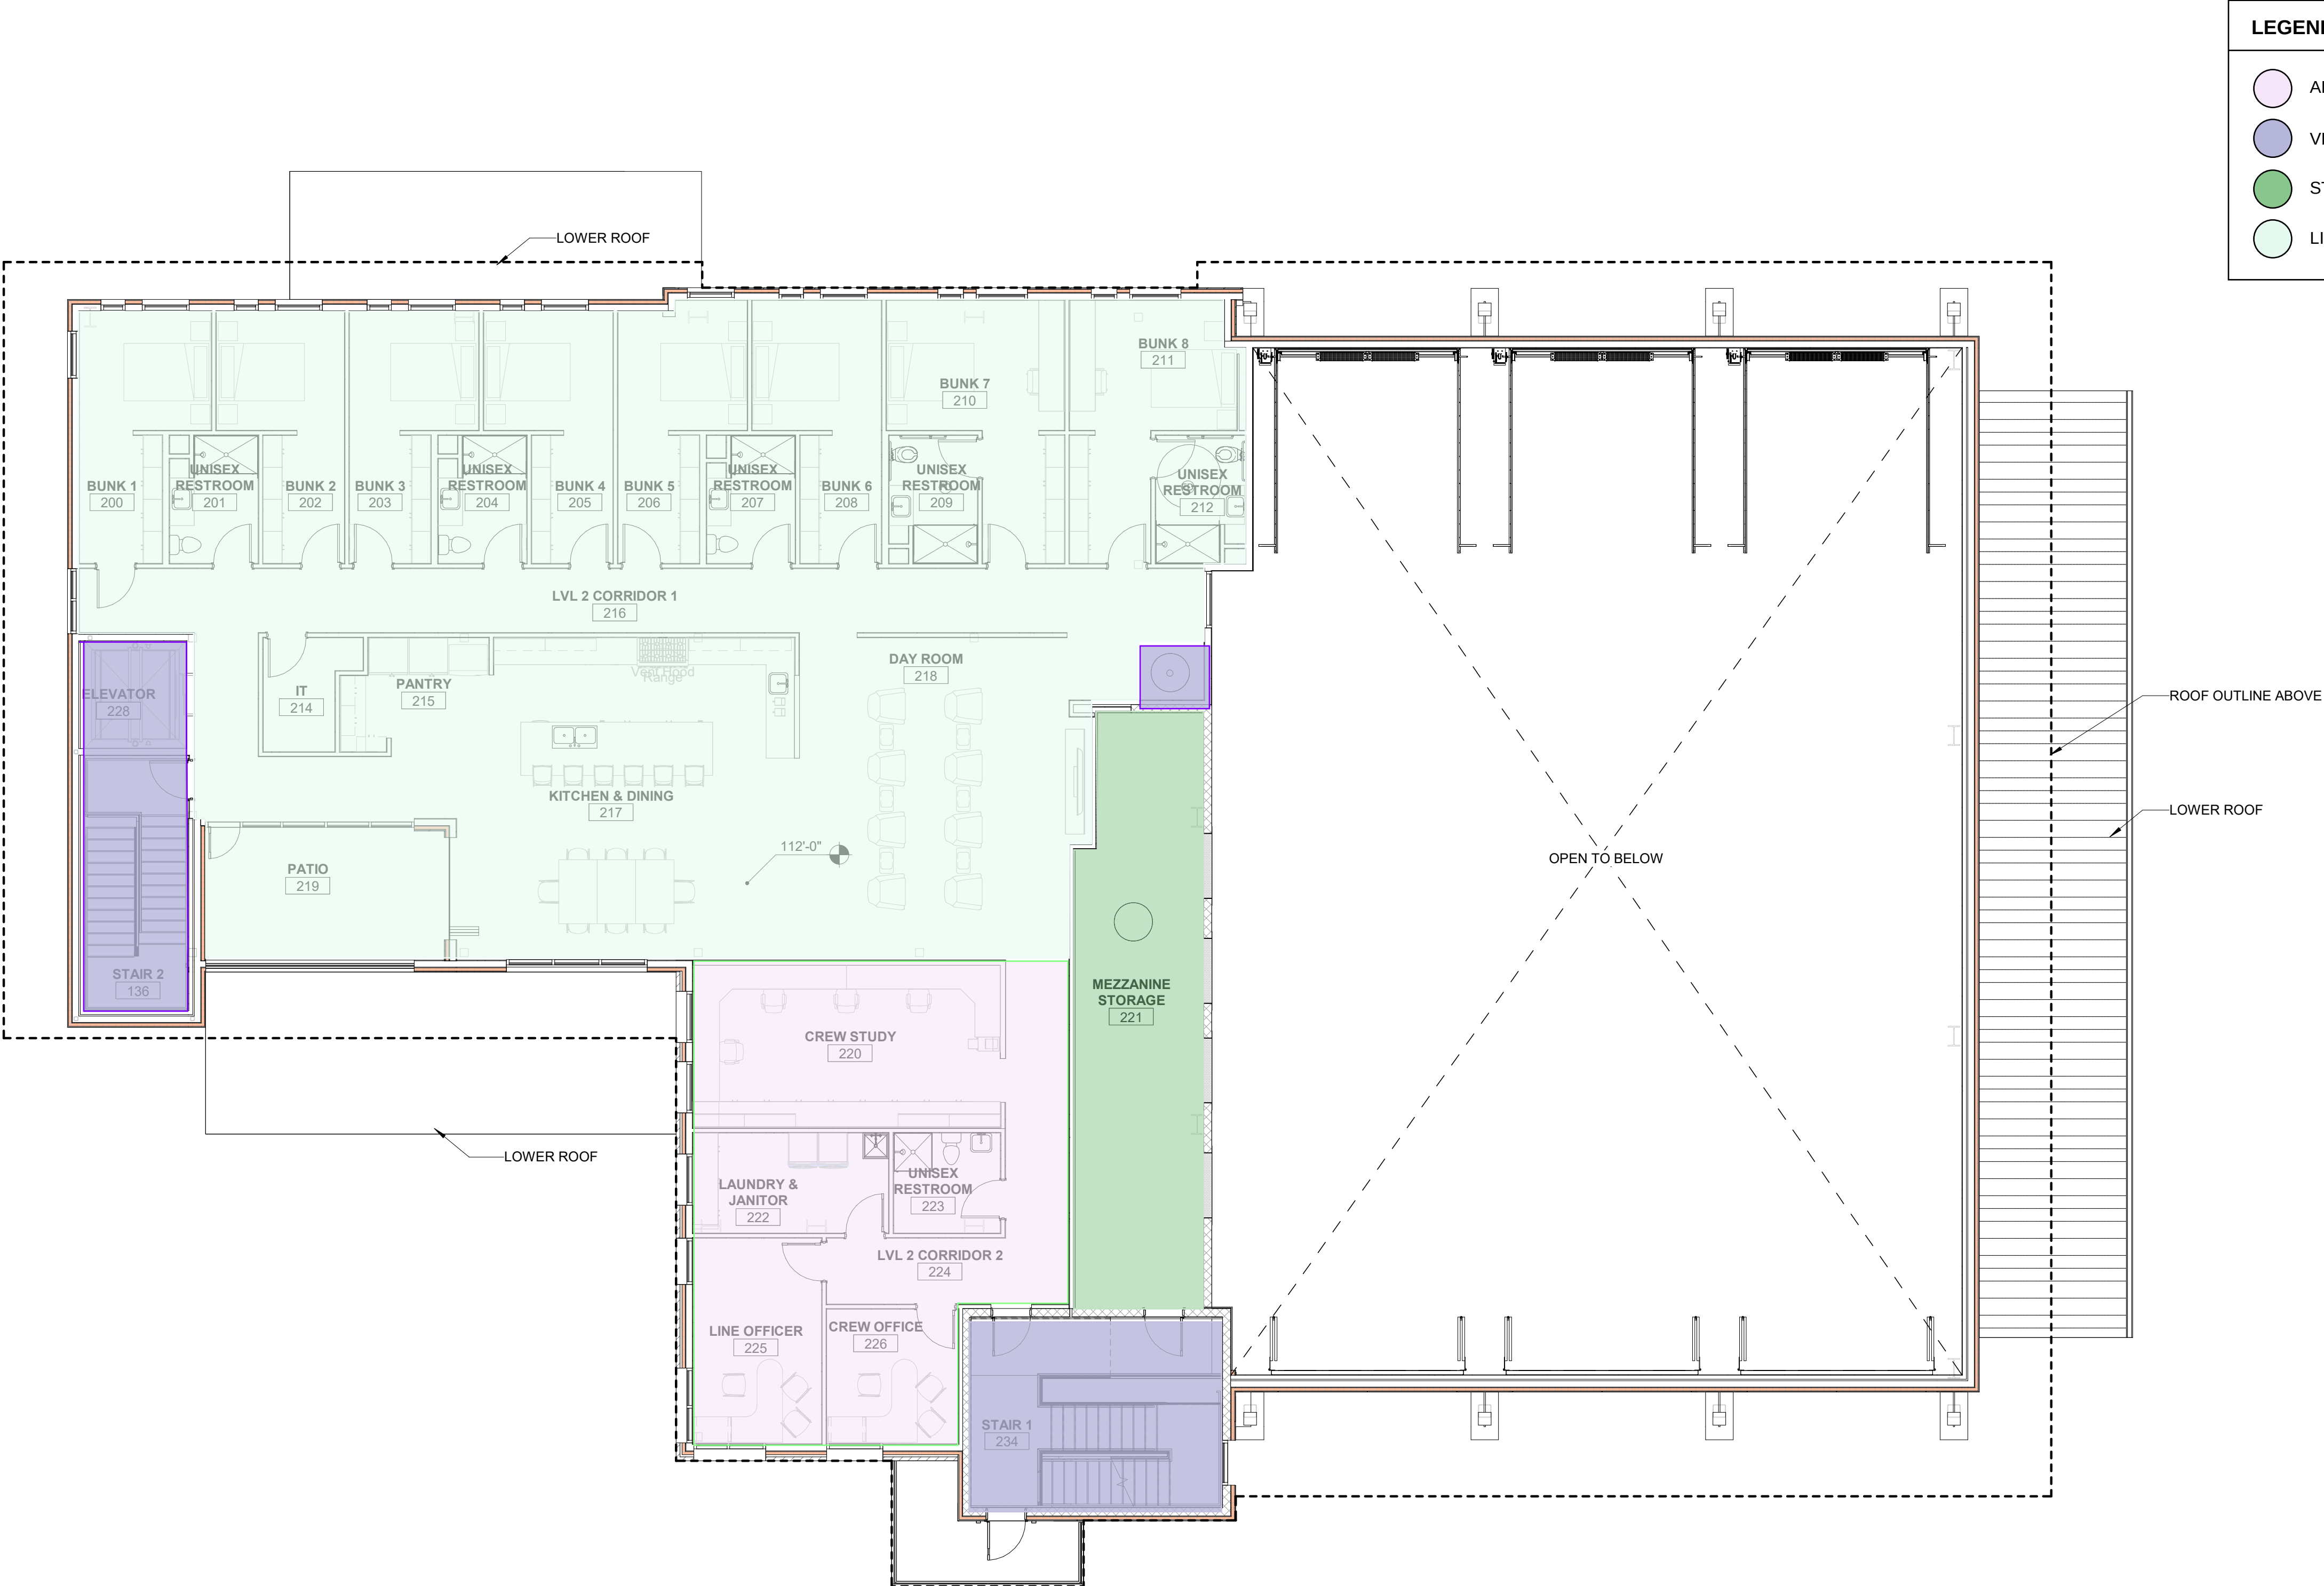

1 FLOOR PLAN - LEVEL 2 OVERALL
1/8" = 1'-0"

STEAMBOAT SPRINGS CITY HALL AND FIRE RESCUE

137 10TH STREET

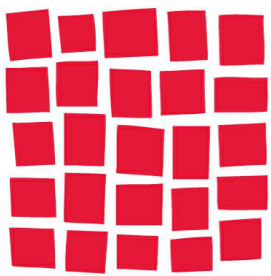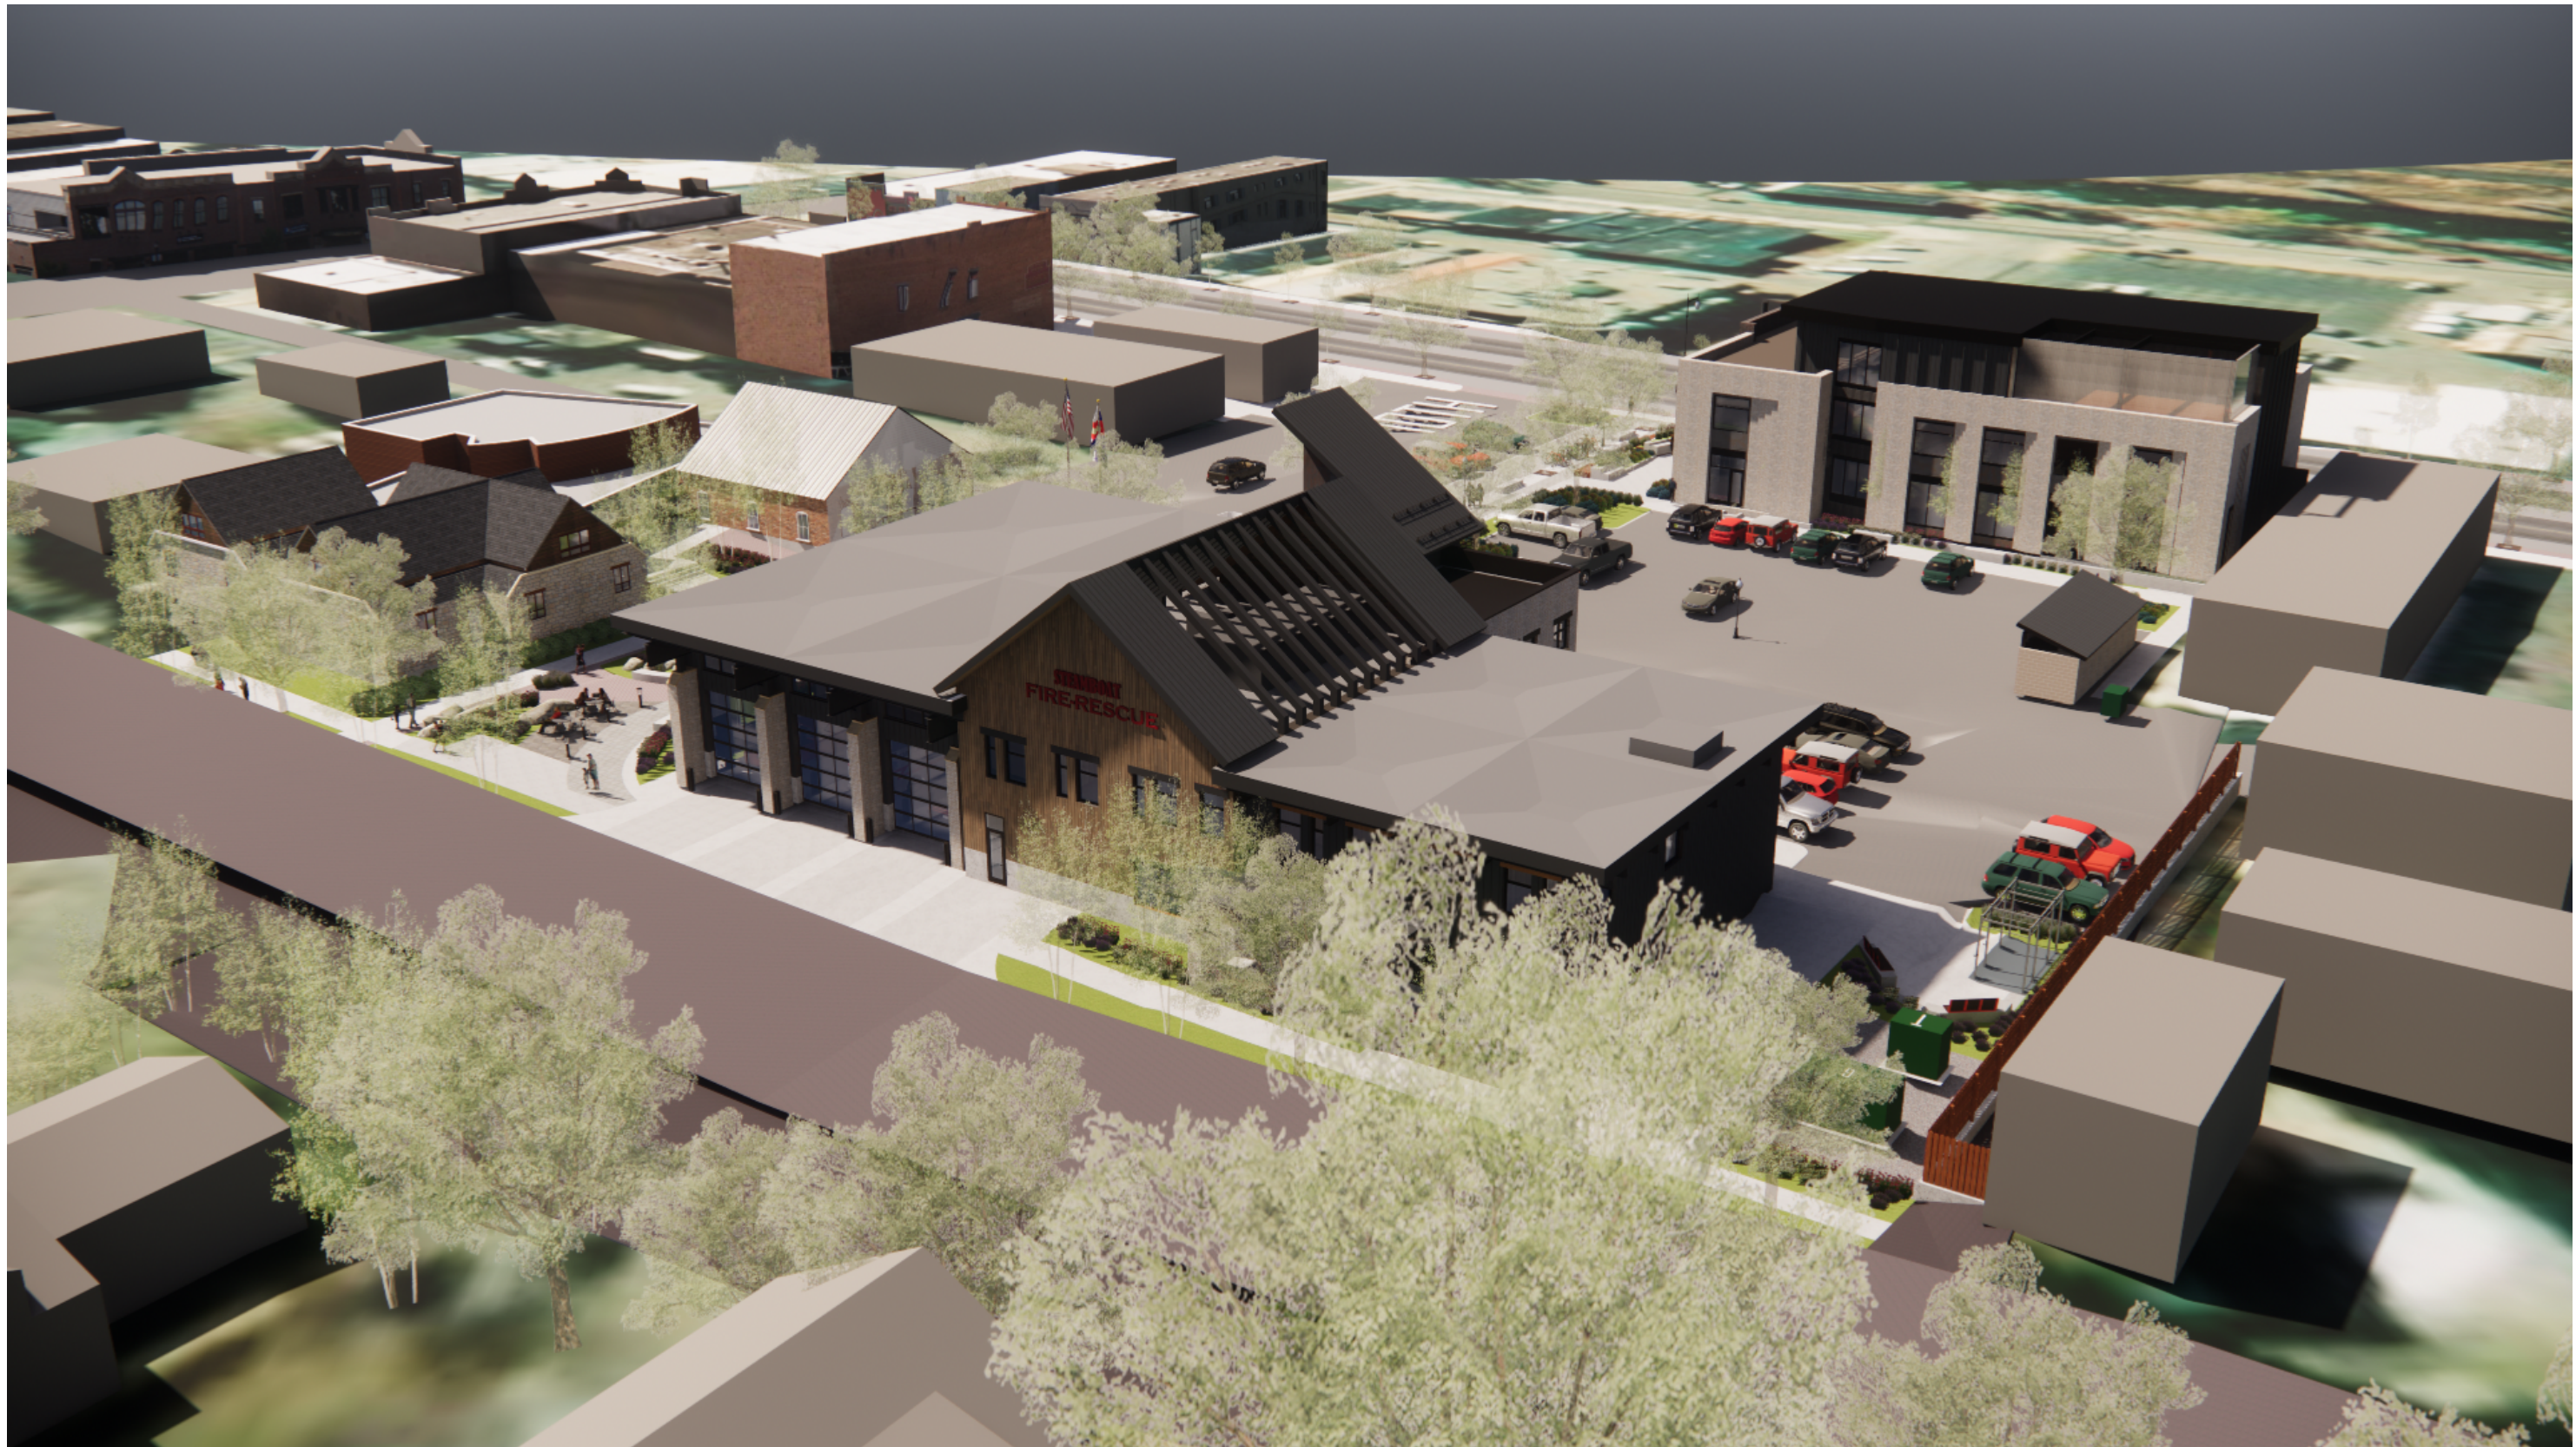

DAVIS
PARTNERSHIP
ARCHITECTS



ANDERSON
HALLAS
ARCHITECTS

SHEET NUMBER:

3

FIRE STATION PERSPECTIVES